


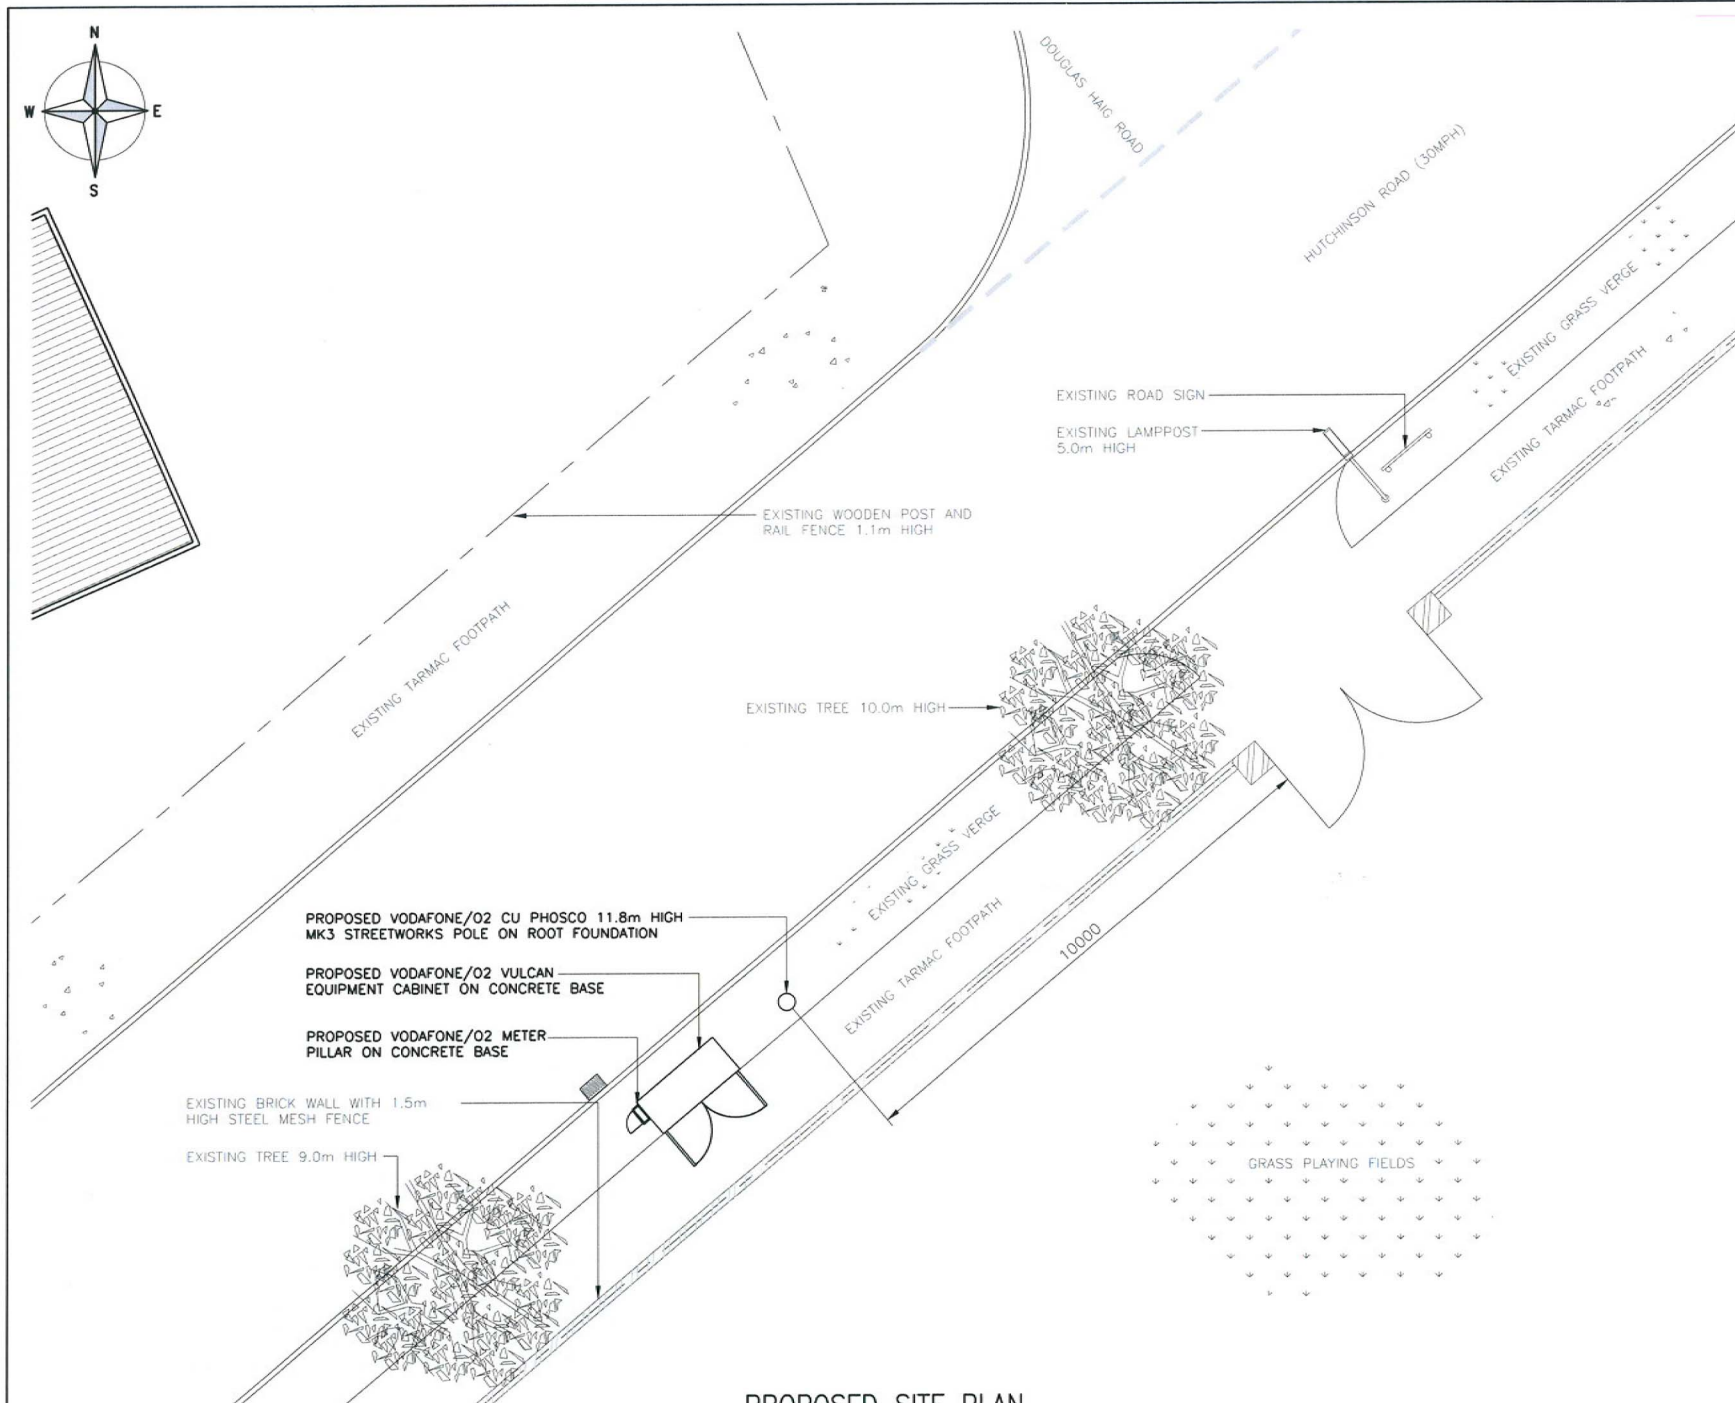

PROPOSED SITE PLAN
(1:100)

The drawings comply with O2 & Vodafone Standard ICNIRP guidelines.
Designed in accordance with Cornerstone document: CORN/09/006

ALL DIMENSIONS ARE IN mm UNLESS NOTED OTHERWISE			
N.G.R		E: 619596 N: 308842	
CONCESSION REQUIRED		NO	
NOTES:			
A Issued for Approval		DW	SR 21.02.12
REV	MODIFICATION	BY	CH DATE
Head Office: Power House, Senator Point, South Boundary Road, Knowsley Industrial Park, Liverpool, L33 7RR Tel: 0151 5464445 Fax: 0151 5471250 Design Office: Portington House, Stock Lane, Chadderton, Oldham, OL9 9EY Tel: 0161 785 4500 Fax: 0161 785 4501 Web: www.clarke-energy.com			
Cornerstone Project			
Cell Name		Opt.	
WEST EARLHAM		-	
Cell ID No			
Cornerstone	Host	Sharer	
(ID)12701	(VF)79549	(O2)045313	
Site Address / Contact Details			
HUTCHINSON ROAD SW NORWICH NORFOLK NR5 8LA			
Drawing Title: PROPOSED SITE PLAN			
Purpose of issue: PLANNING			
Drawing Number: 200			
Surveyed By: SR		Original Sheet Size: A3	Issue:
Drawn: DW	Date: 21.02.12	Checked: SR	Date: 21.02.12
			A